


DEPT. No	DEPT. NAME	TOTAL HEAD COUNT	NAME	No
	HR/Facilities	1	Goye Lunau	201
TOTAL		1		

March 4th 2008  
12th floor

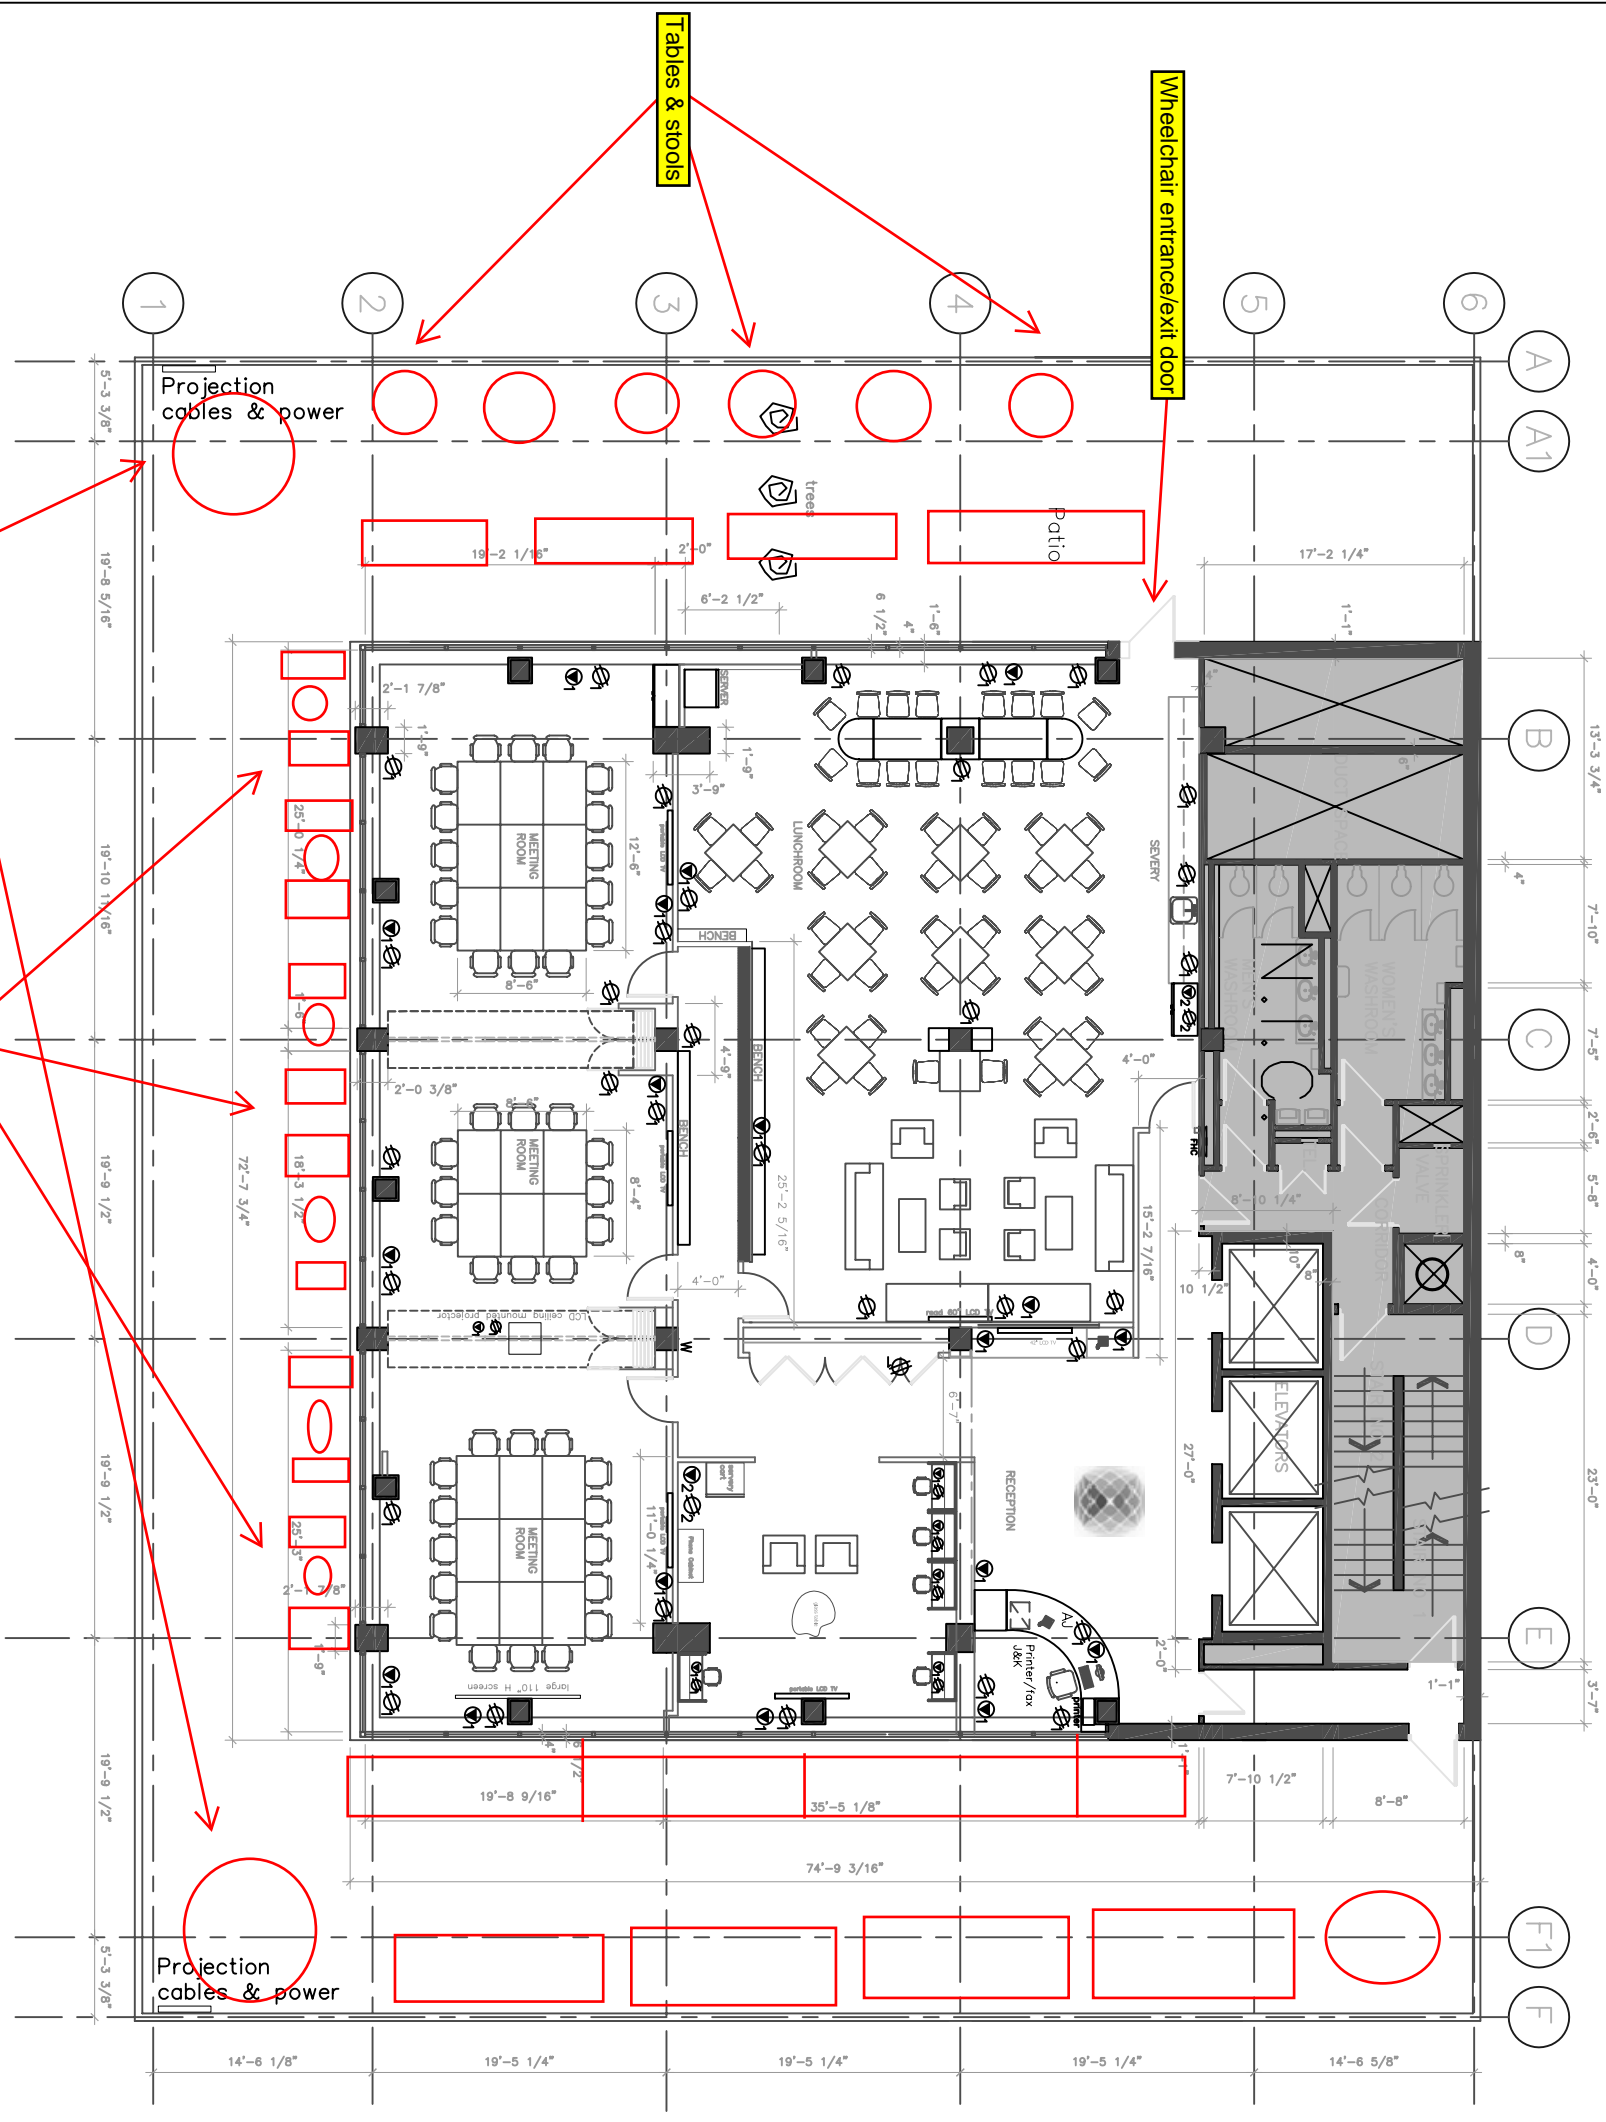

W: wireless  
 ●: data lines  
 ⊗: duplex  
 A: analog/OPX

Thursday May 31st 2007

NO.	REVISION	DATE	DWN.



DRAWN BY : SSENSES  
 DATE : MAY31.07  
 CHECKED BY :  
 SCALE :  
 PROJECT:

12th floor plan

JOB No: **3**